


WATER RISER
SCALE: N.T.S.

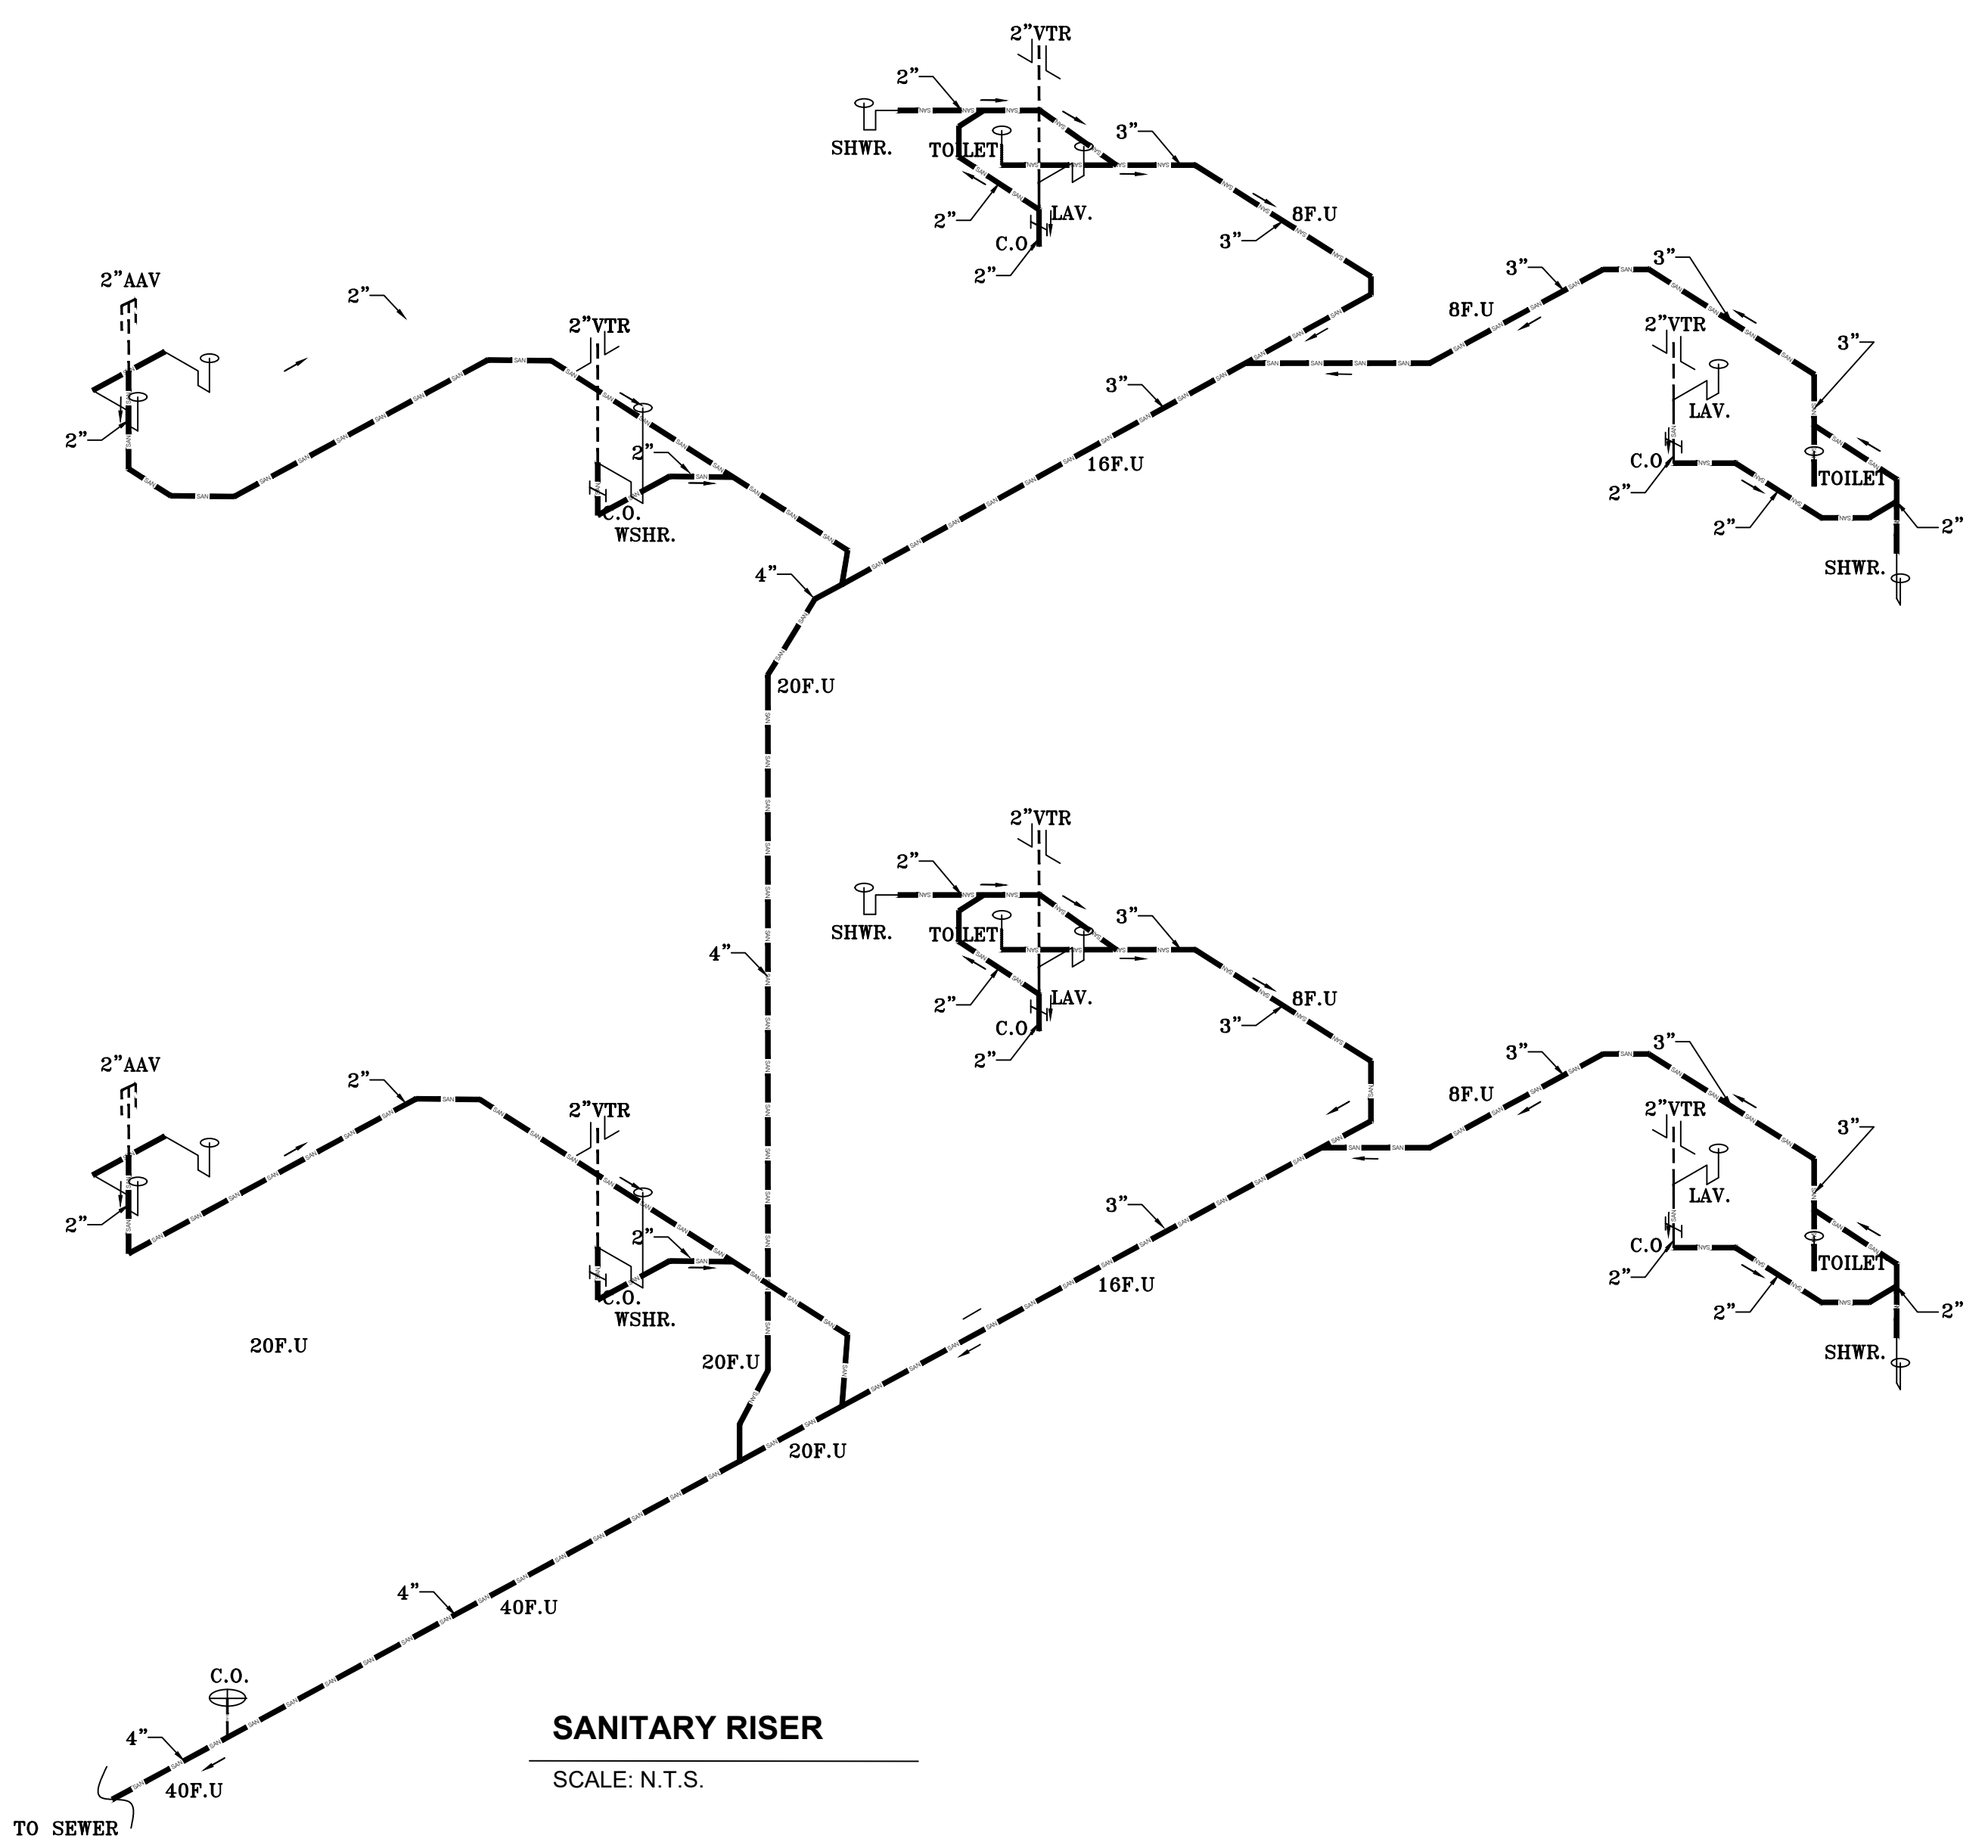

SANITARY RISER
SCALE: N.T.S.

SANTIAGO BOLLIVAR, P.E.
CONSULTING ENGINEER
FL. LIC. No. 53326
265 S. FEDERAL HWY # 453
DEERFIELD BEACH, FL. 33441
TEL: (786) 571-9603

New Duplex
Two Story Residence
1035 N.W. 75 Street
Miami, fl 33150

Project Title: _____
Address: _____

Plumbing Risers

REVISIONS
05.20.191.V.L

DESCRIPTION
Date: _____
Drawn By: _____

Approved By: _____

SEAL

SHEET NO.

P-3.0

14 | 21

THESE DRAWINGS AND DESIGNS ARE THE PROPERTY OF SANTIAGO BOLLIVAR, P.E. AND SHALL NOT BE REPRODUCED WITHOUT HIS WRITTEN CONSENT.